

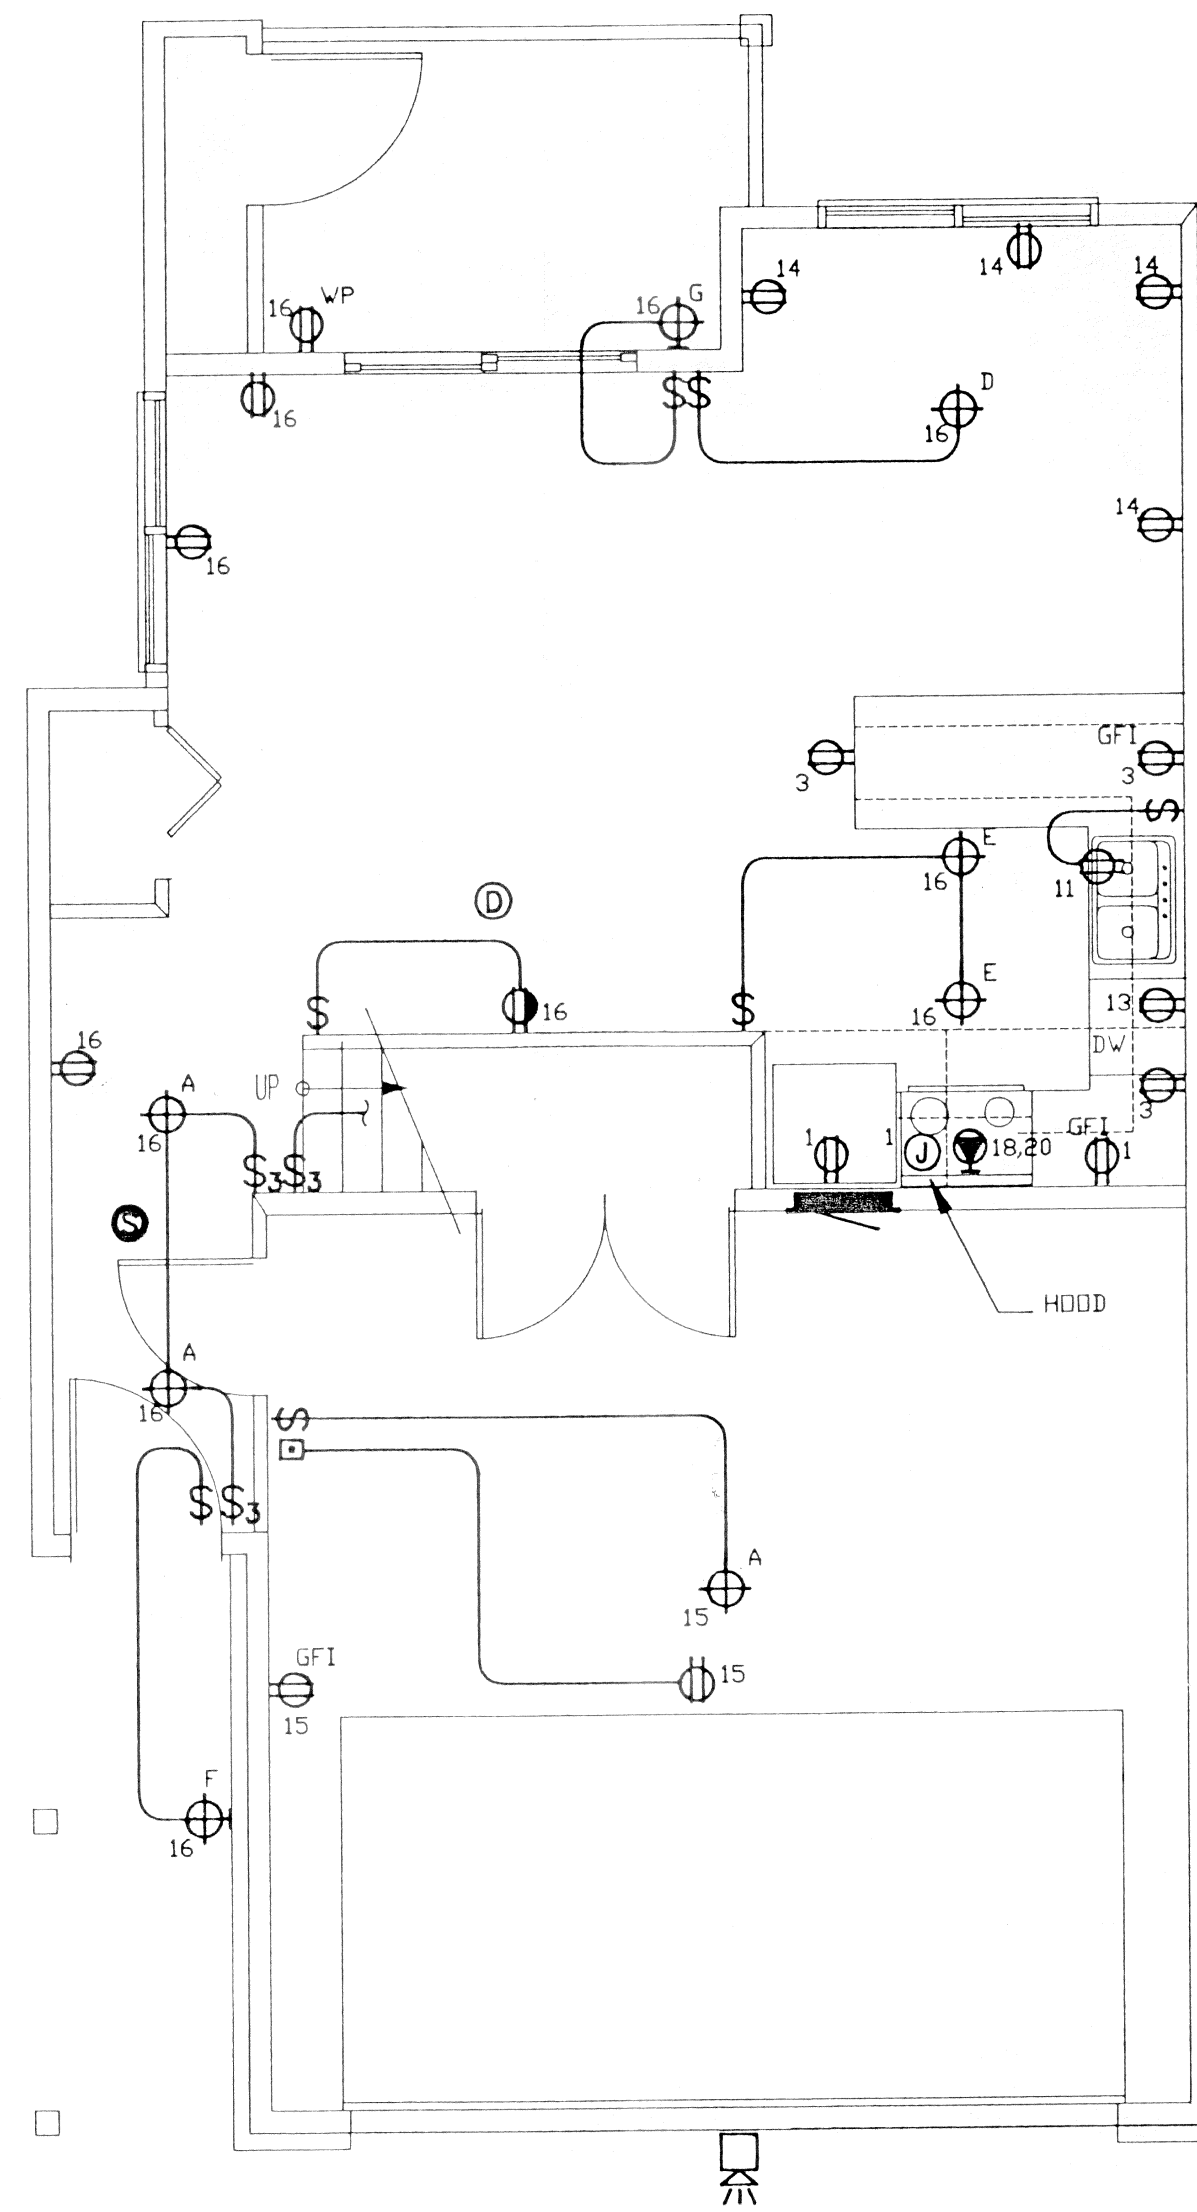
 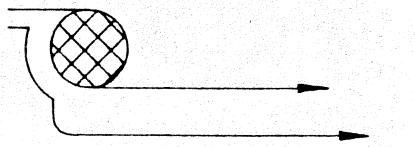



DESIGN GROUP INC
ELECTRICAL-DESIGN
P.O. BOX 764
GLENWOOD SPRINGS
COLO. 81601

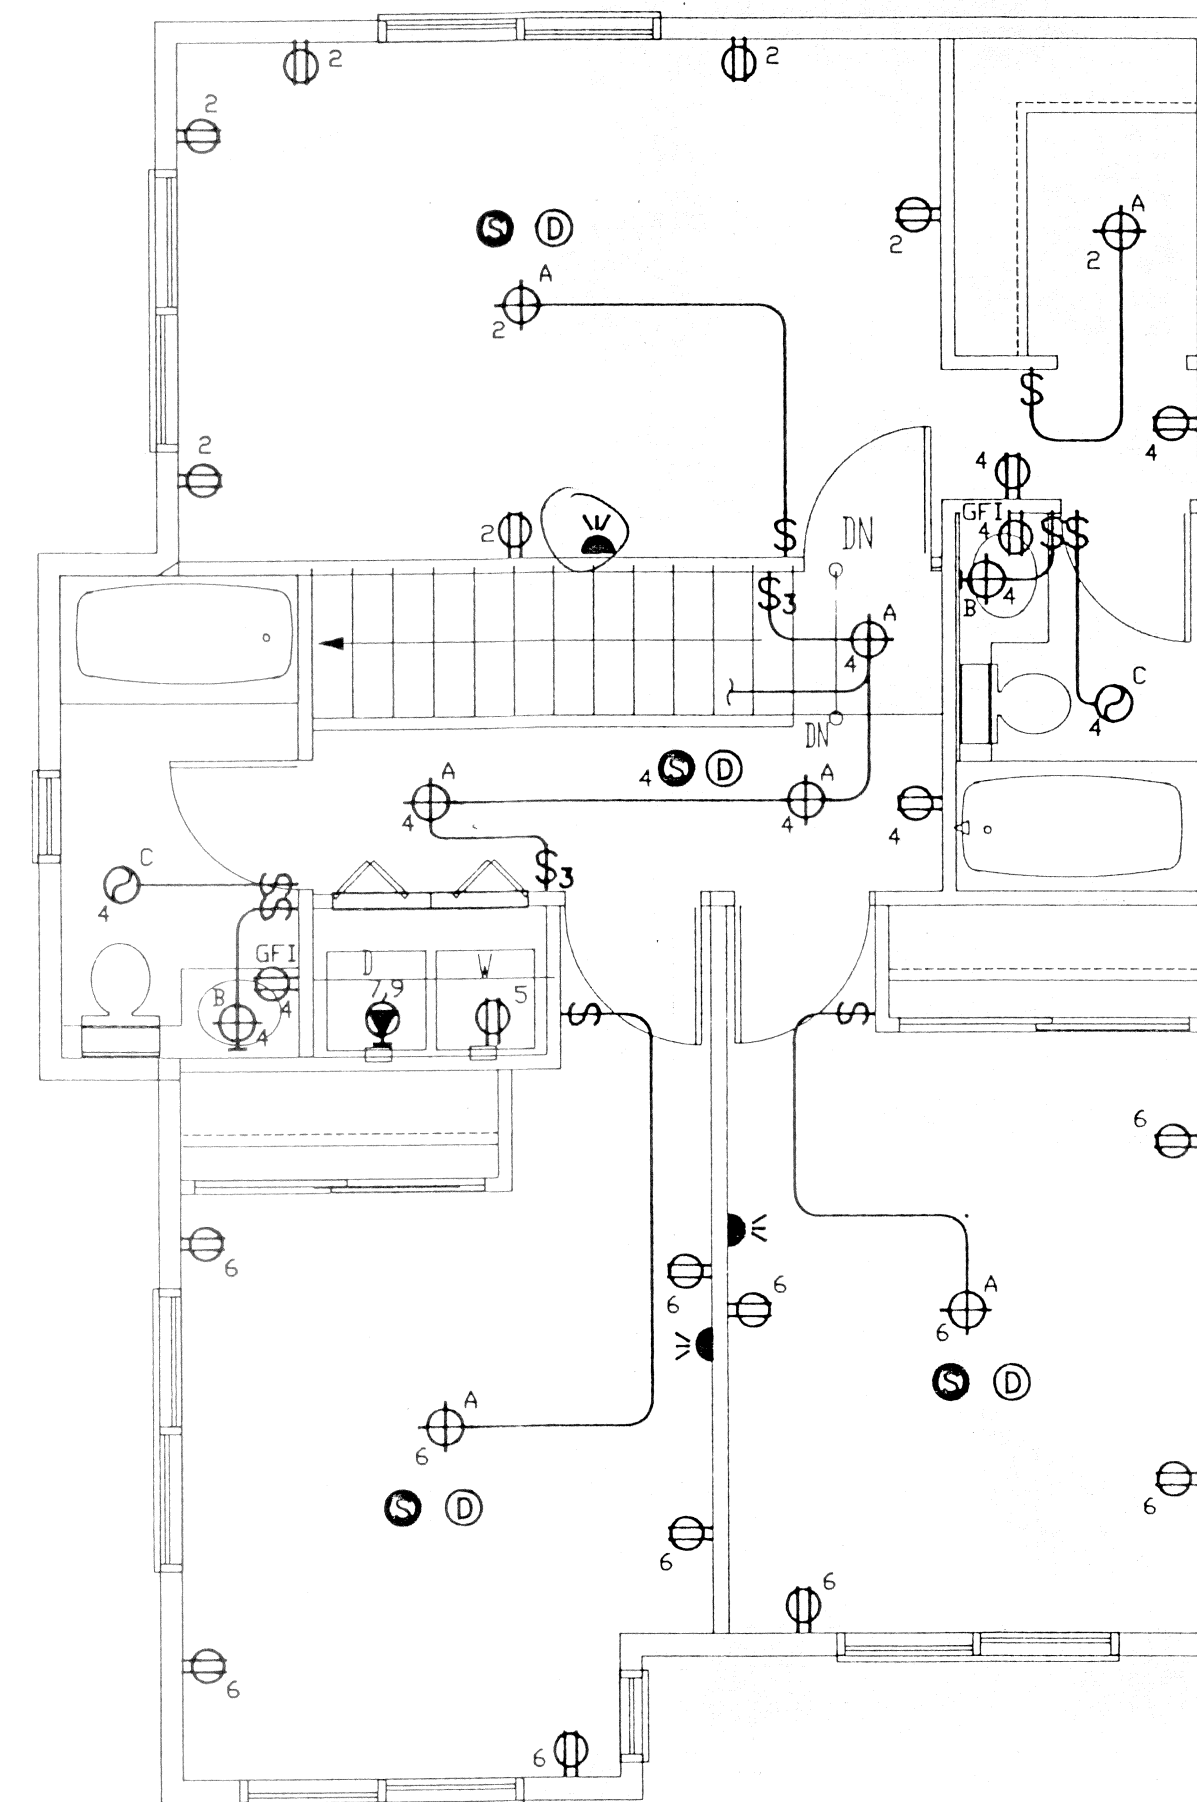

LOWER LEVEL-END
BUILDINGS 1,2,3 & 4



 UPPER LEVEL-END
BUILDINGS 1,2,3 & 4



Smoke detectors are required
in each bedroom, bedroom
corridor, on every level,
wired to electrical system
and have battery back-up
Sec. 1210

MOUNTAIN
HOUSING GROUP
LOT 640C
TELLURIDE MOUNTAIN VILLAGE

JOB # 93184
DRAWN SW
CHECKED ROSS HANSEN
PRINTED 3-10-94

SHEET TITLE:
ELECTRICAL PLANS

E2.7

