

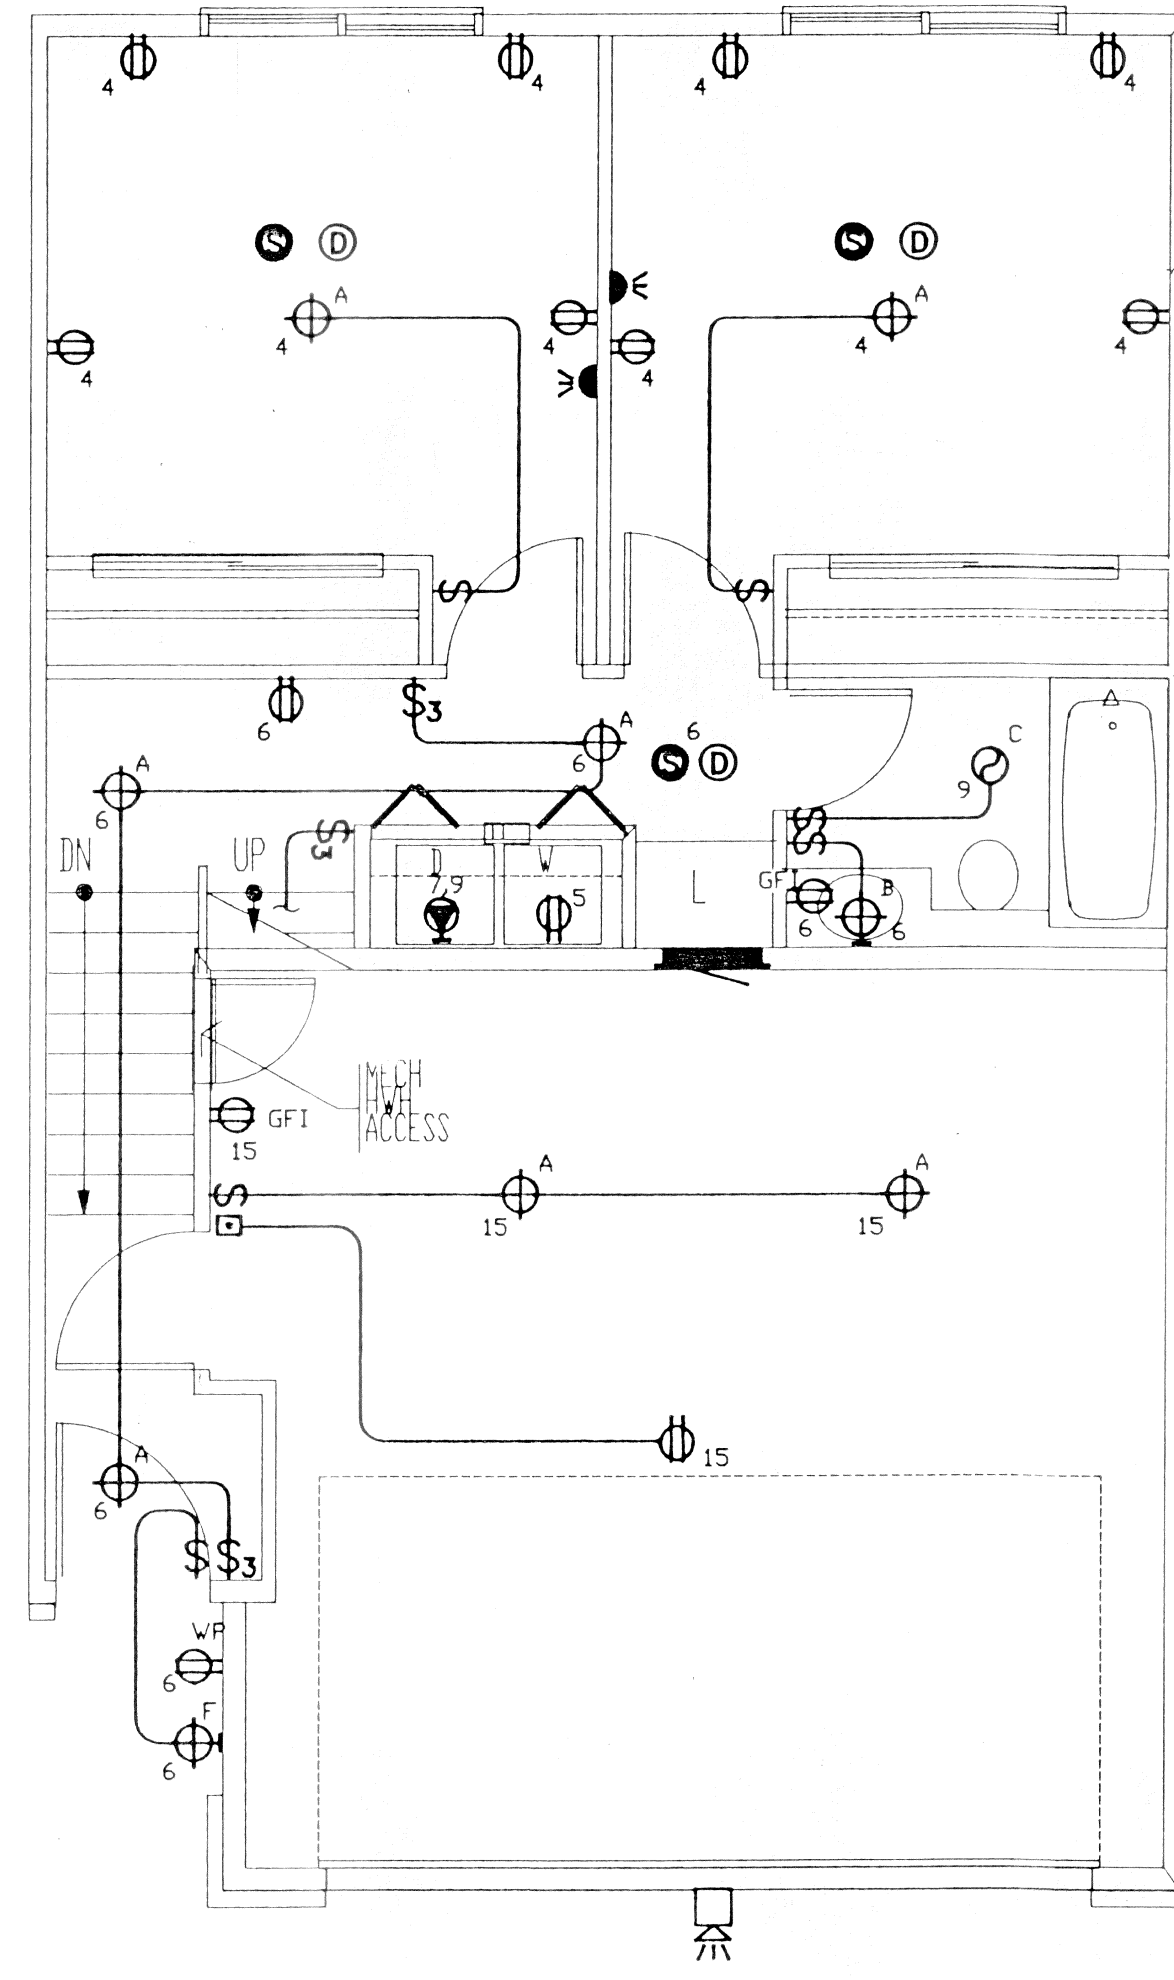
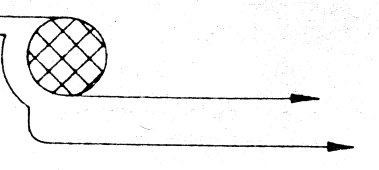



DESIGN GROUP INC
 ELECTRICAL-DESIGN
 P.O. BOX 764
 GLENWOOD SPRINGS
 COLO. 81601

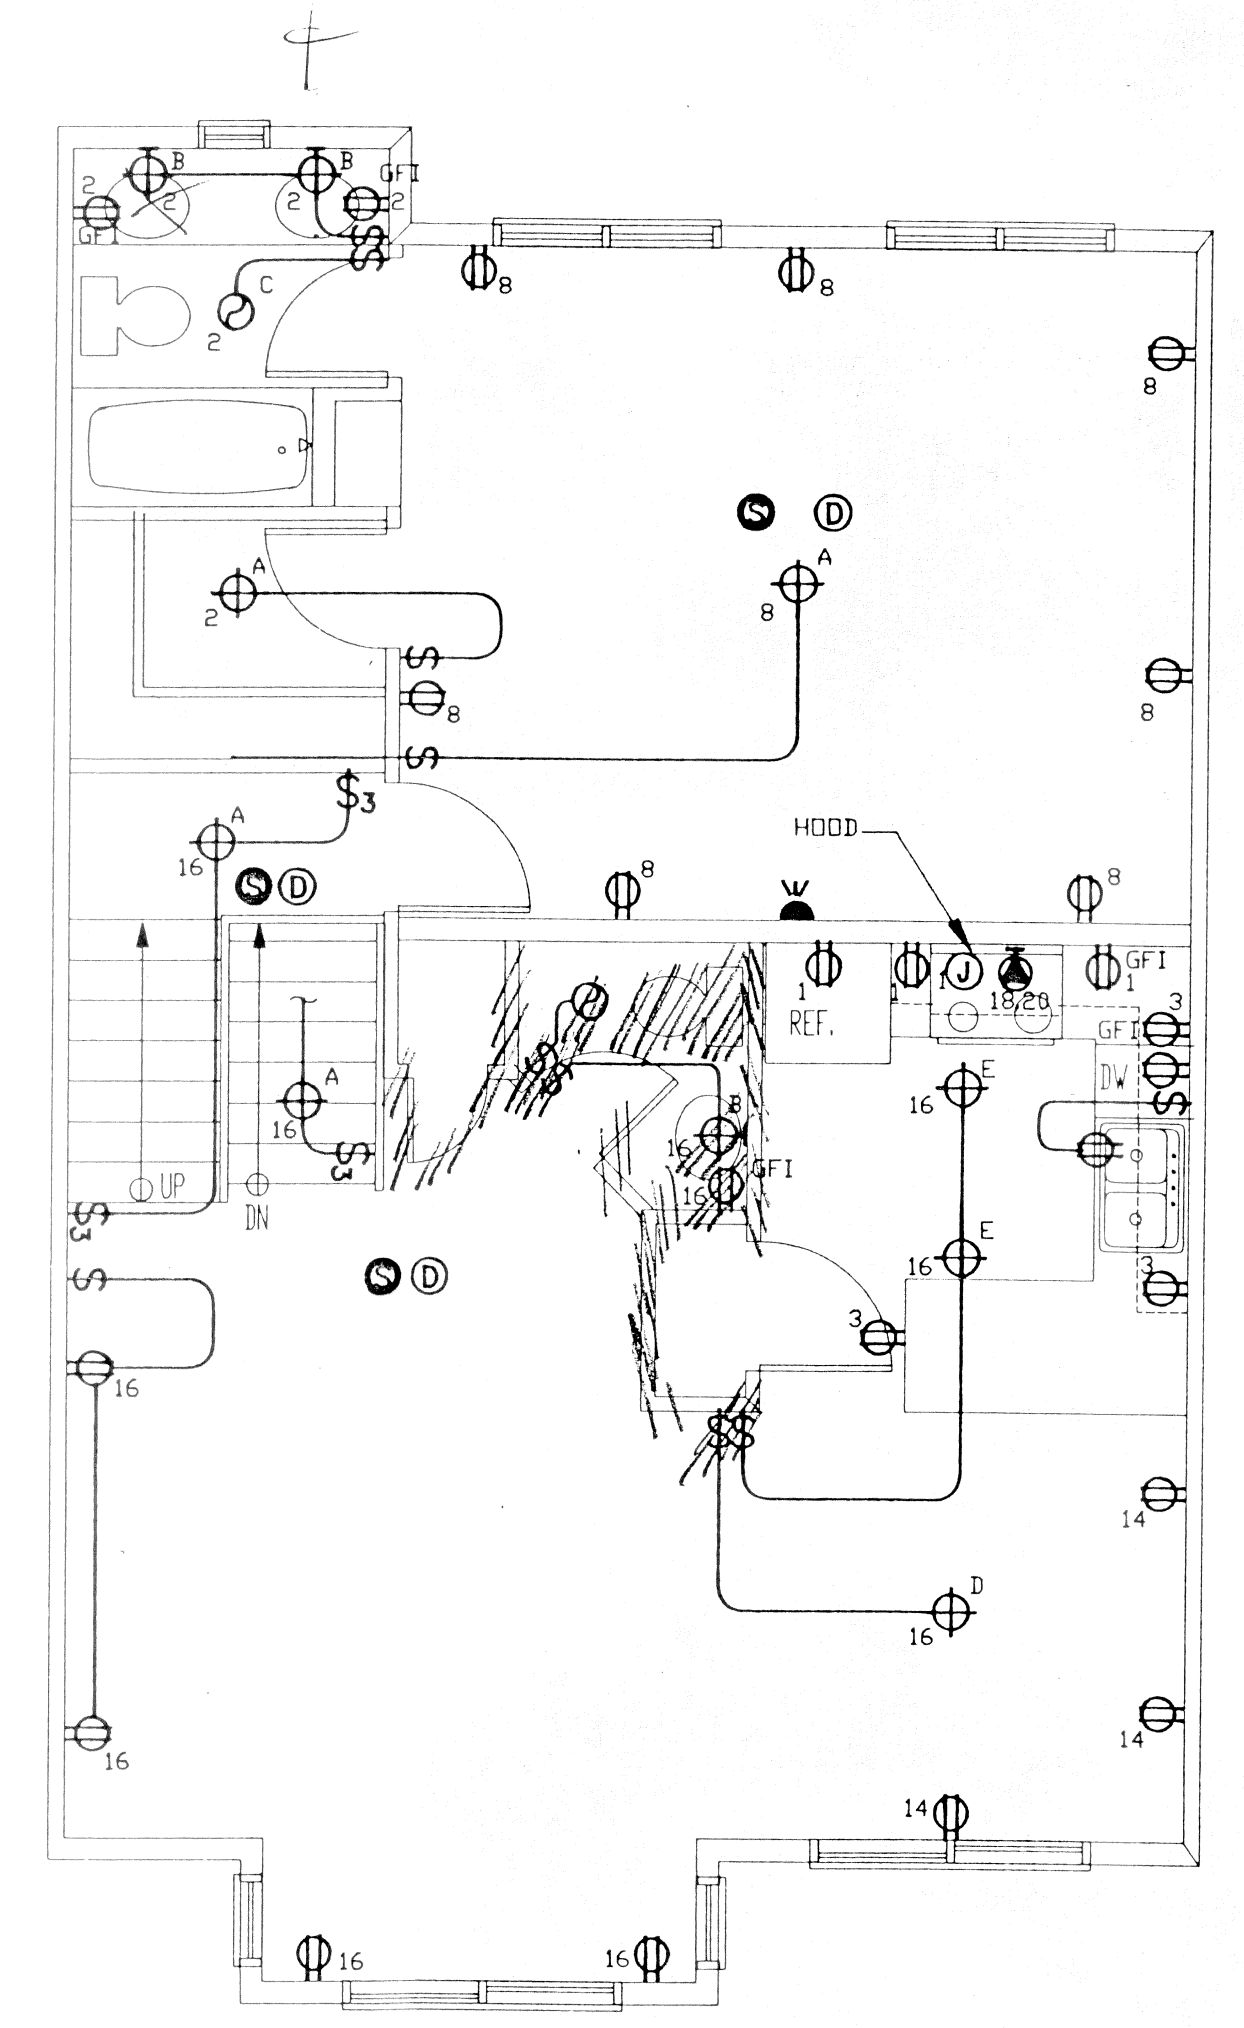

LOWER LEVEL
 BUILDINGS 1,2,3 & 4

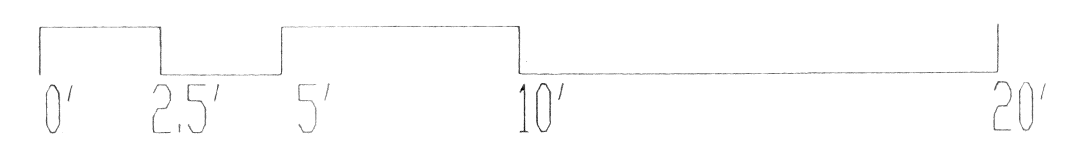

UPPER LEVEL
 BUILDINGS 1,2,3 & 4

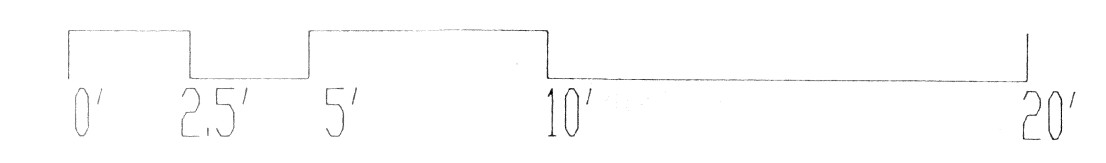

Smoke detectors are required
 in each bedroom, bedroom
 corridor, on every level,
 wired to electrical system
 and have battery back-up
 Sec. 1210

DATE	REMARKS

MOUNTAIN
 HOUSING GROUP
 LOT 640C
 TELLURIDE MOUNTAIN VILLAGE

JOB # 93184
 DRAWN SW
 CHECKED ROSS HANSEN
 PRINTED 3-10-94

SHEET TITLE:
 ELECTRICAL PLANS



E2.8