

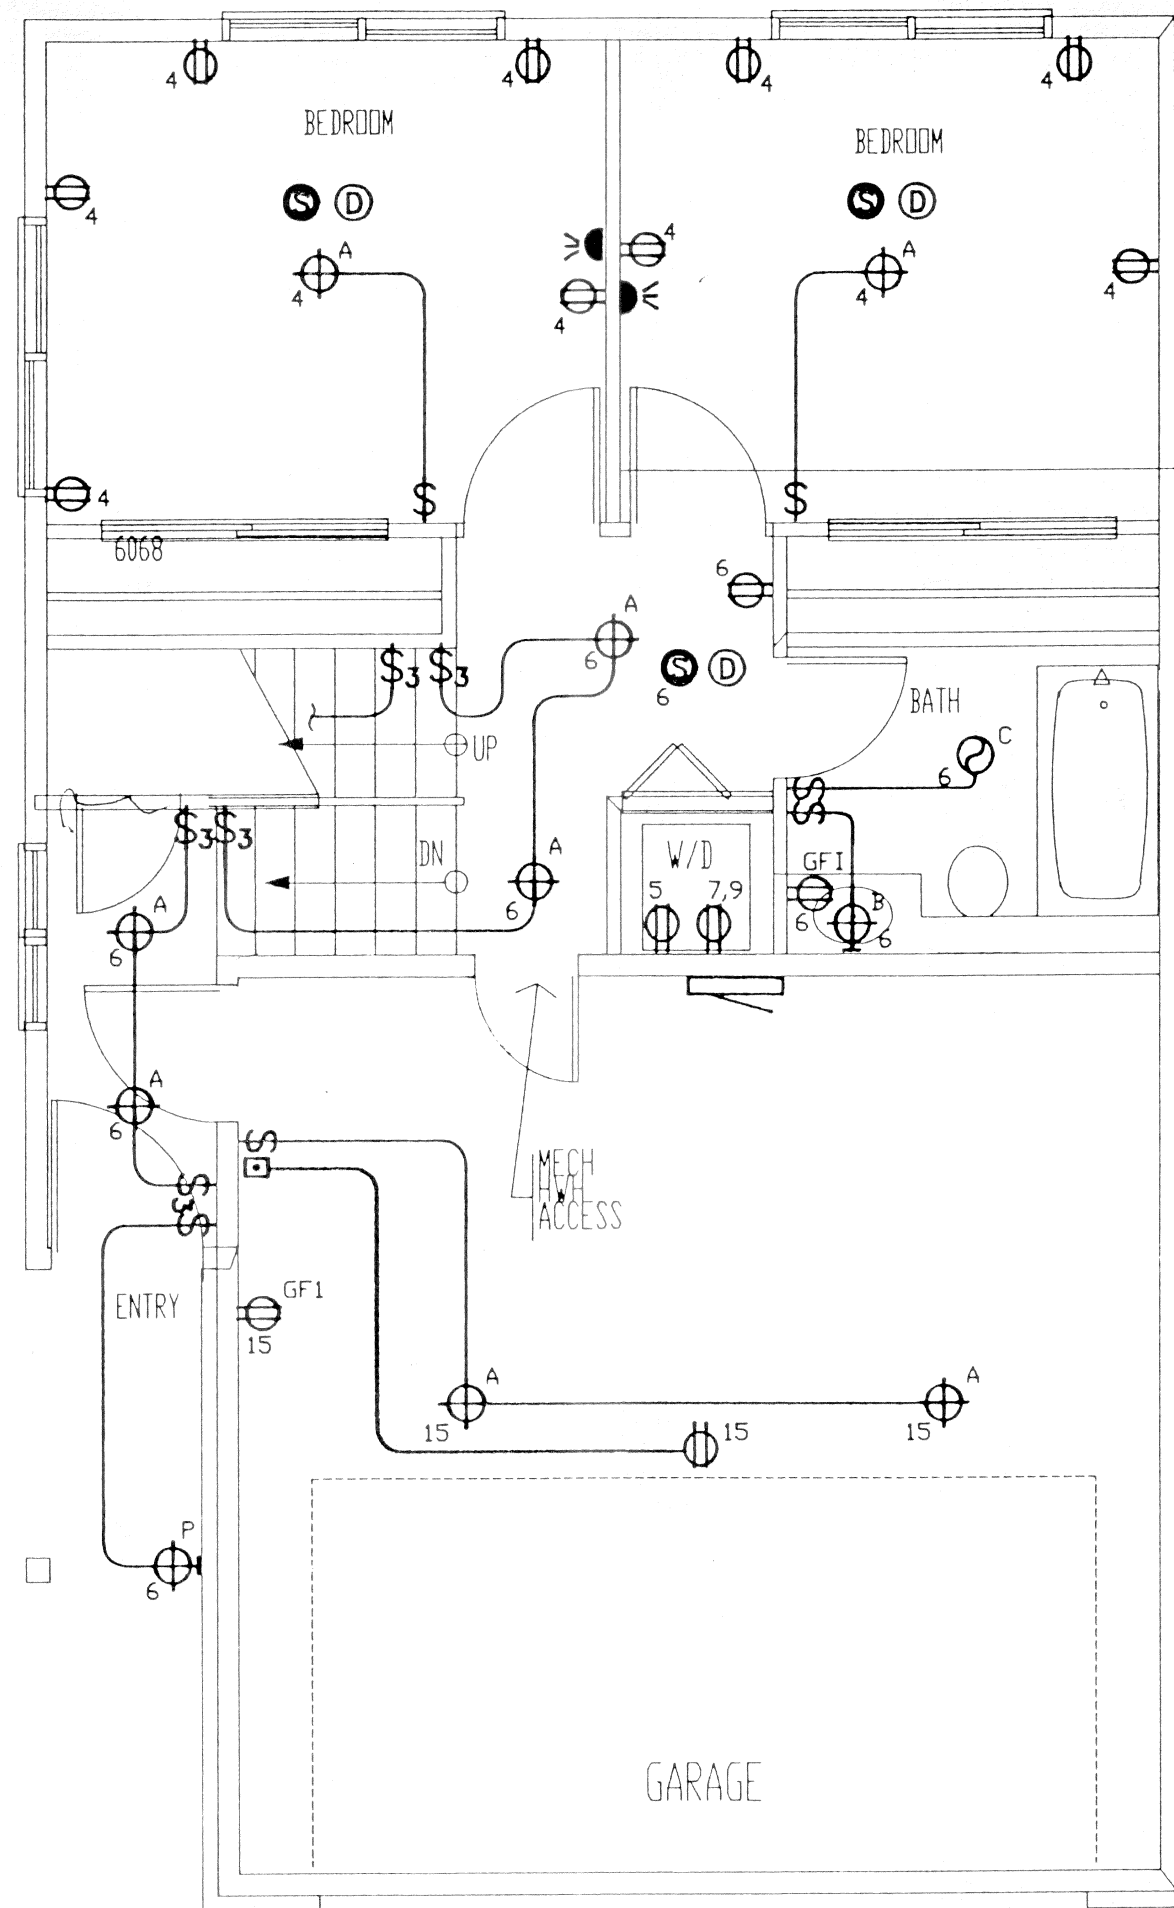
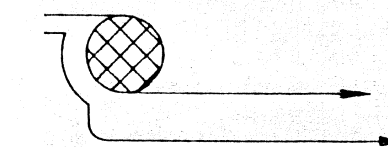


David Platt
Approval
1-16-94
S&L minor change


DESIGN GROUP INC
ELECTRICAL-DESIGN
P.O. BOX 764
GLENWOOD SPRINGS,
COLO. 81601

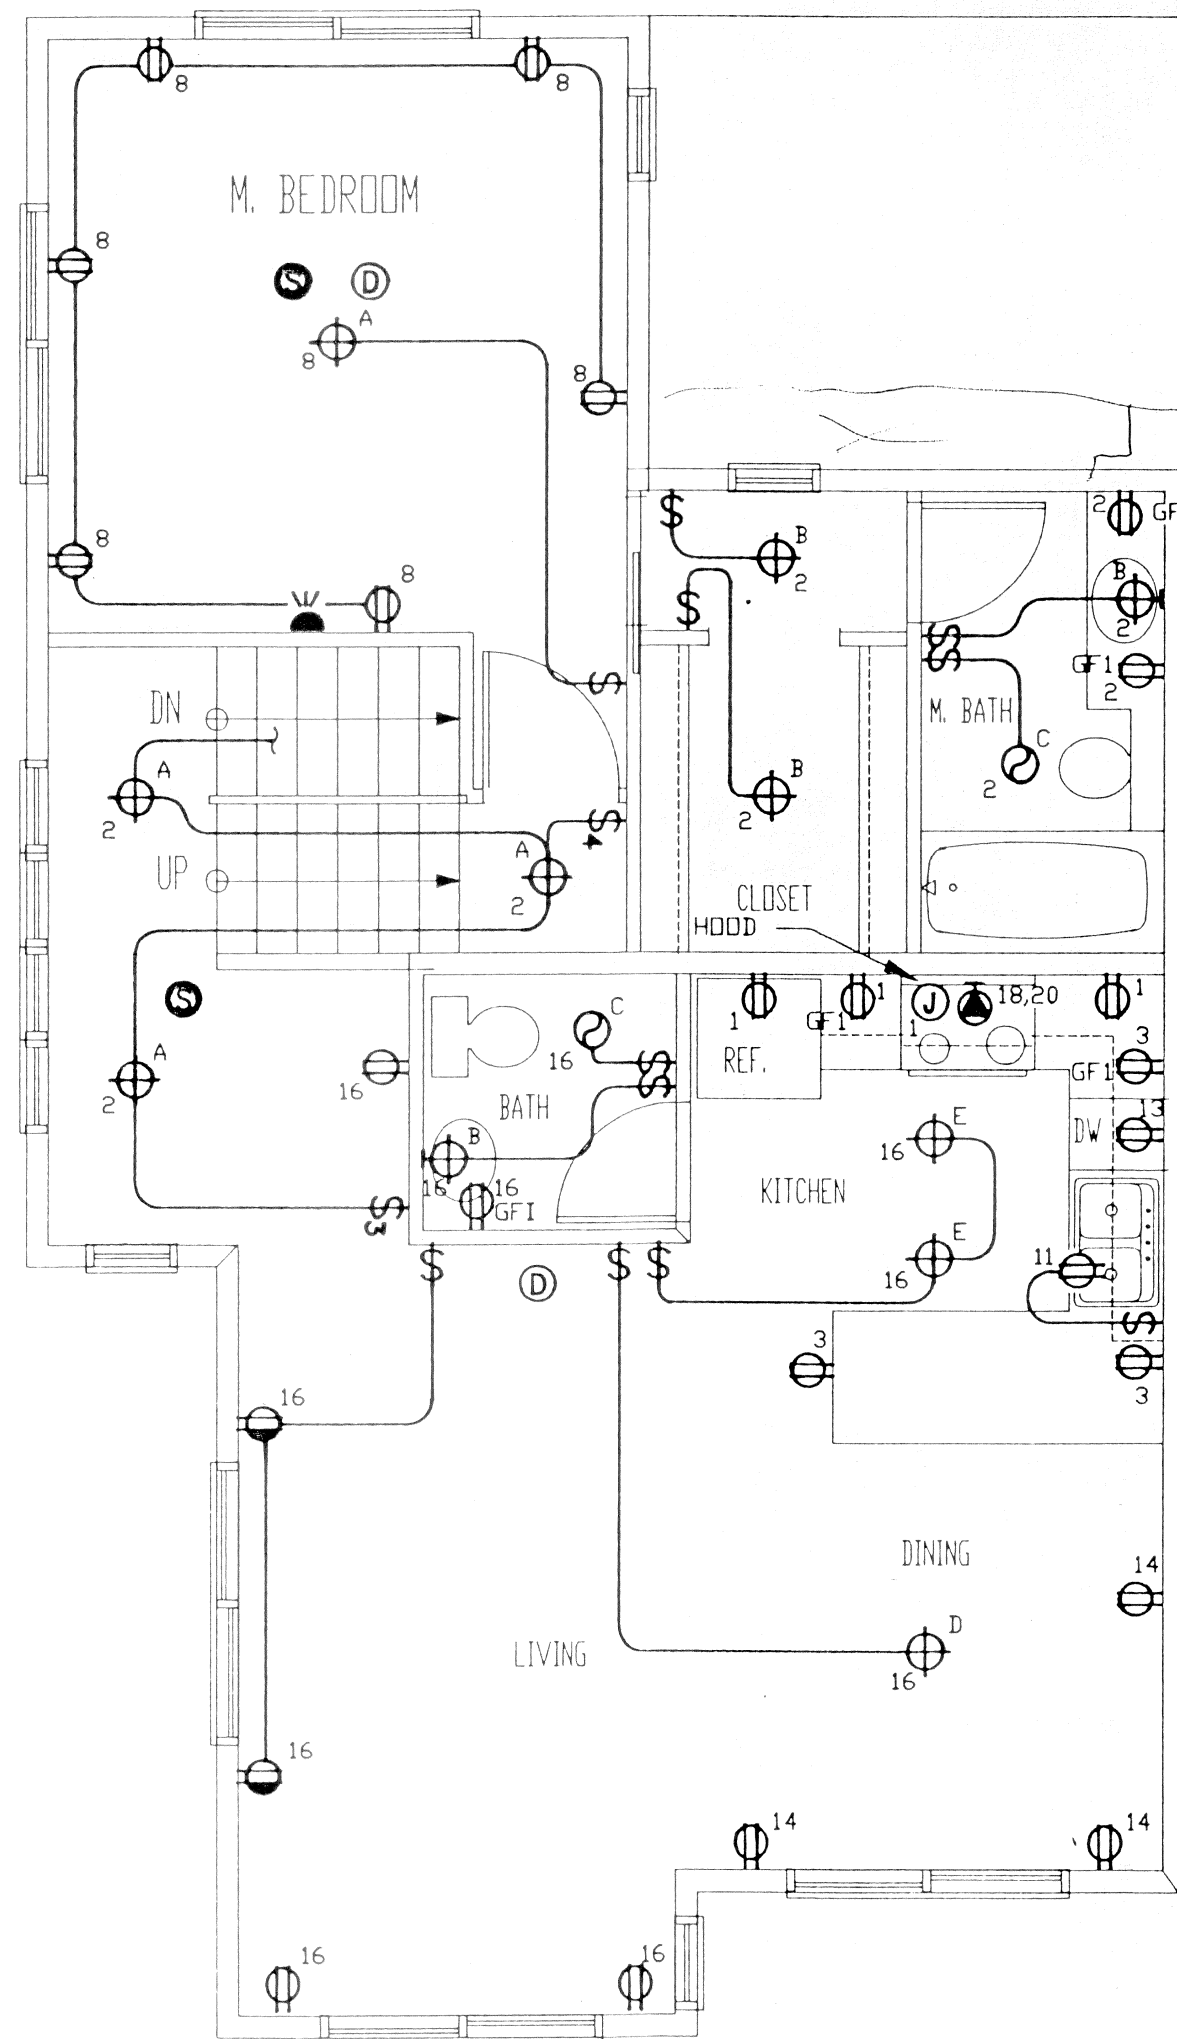

LOWER LEVEL-END
BUILDINGS 1,2,3 & 4

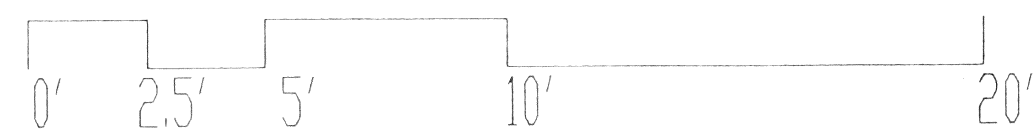

UPPER LEVEL-END
BUILDINGS 1,2,3 & 4

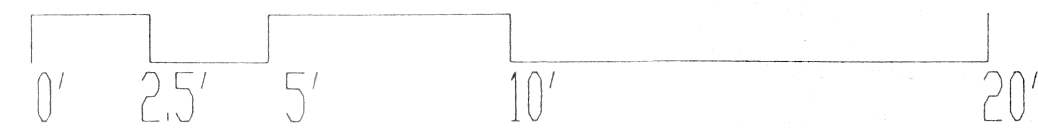


Smoke detectors are required
in each bedroom, bedroom
corridor, on every 10' run,
wired to electrical system
and have battery back-up
Sec. 1210

MOUNTAIN
HOUSING GROUP
LOT 640C
TELLURIDE MOUNTAIN VILLAGE

JOB #	93184
DRAWN	SV
CHECKED	ROSS HANSEN
PRINTED	3-10-94

SHEET TITLE:
ELECTRICAL PLANS

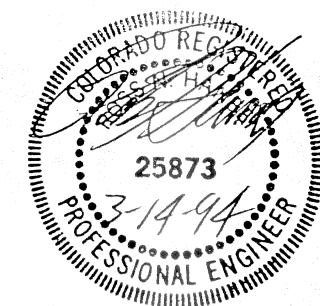

E2.9