
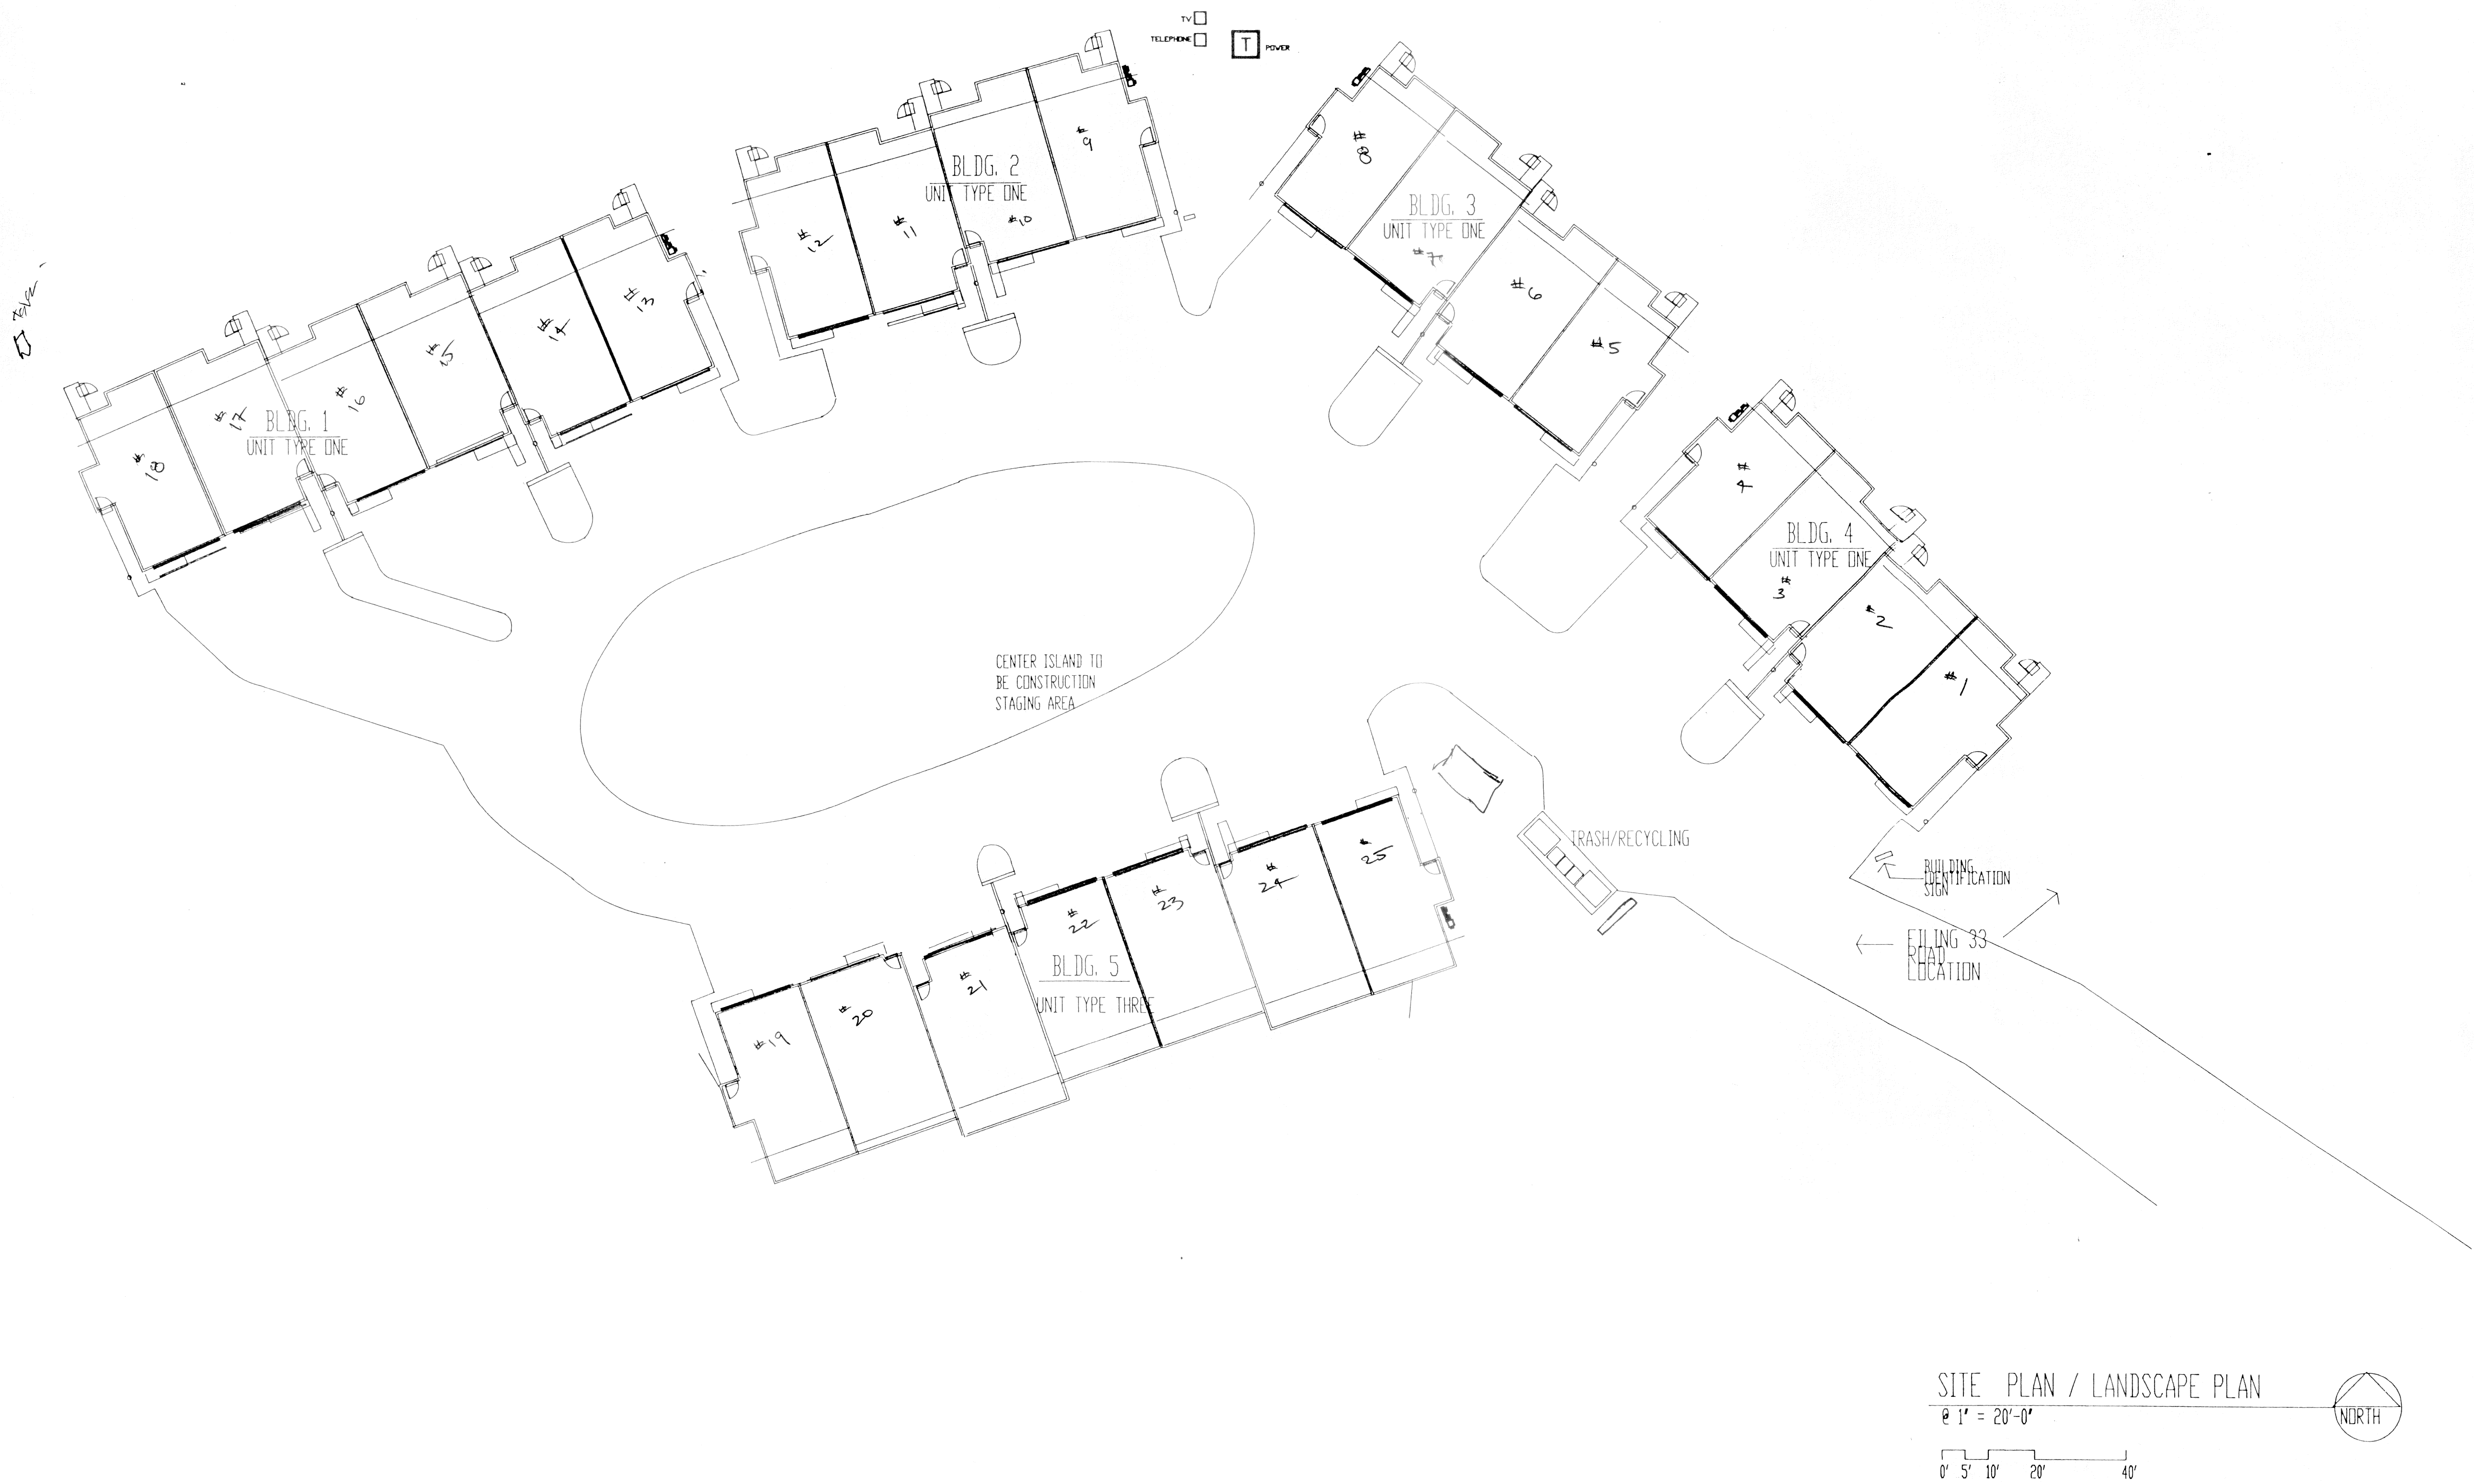


DESIGN GROUP INC
ELECTRICAL-DESIGN
P.O. BOX 764
GLENWOOD SPRINGS
COLO. 81601

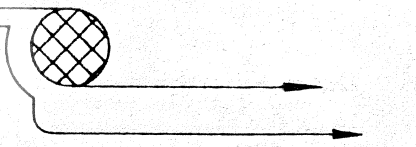

DATE	REMARKS

MOUNTAIN
HOUSING GROUP
LOT 640C
TELLURIDE MOUNTAIN VILLAGE

JOB # 93184
DRAWN SW
CHECKED ROSS HANSEN
PRINTED 3-10-94

SHEET TITLE:
ELECTRICAL PLANS

— SITE
— ELECTRICAL

